



MUNICIPAL SERVICES AGENCY  
DEPARTMENT OF COUNTY ENGINEERING

Architectural  
Services  
**ASD**  
Division  
10545 ARMSTRONG AVE, SUITE 201A  
MATHER, CA 95655  
(916) 876-8300

CONSULTANTS

**GEORGE MIERS & ASSOCIATES**  
Architecture/Planning  
Interior Design  
1150 Moraga Way, Suite 150  
Moraga, CA 94556  
(925) 631-6000  
(925) 631-6910 fax

ARCHITECT/ENGINEER OF RECORD

**ANIMAL CARE and REGULATION  
NEW FACILITY  
3839 BRADSHAW RD  
SACRAMENTO, CA**

PROJECT TITLE

DRAWING RELEASE

DESCRIPTION	DATE
CD SET	01/12/07

REVISIONS

No.	DESCRIPTION	DATE

DESIGN BY: GM

DRAWN BY: ELJP

CHKD BY:

DATE: 01/29/07

SCALE: 1" = 30'-0"

PFM No:

CONTRACT No: 3814

PROJECT NO: 2001001

CAD DWG FILE:

FACILITY CODE:

SHEET TITLE

**SITE PLAN**




ALT A - STAFF ENTRANCE

SECURITY GATES

SHEET No:

**A1.0**

OF

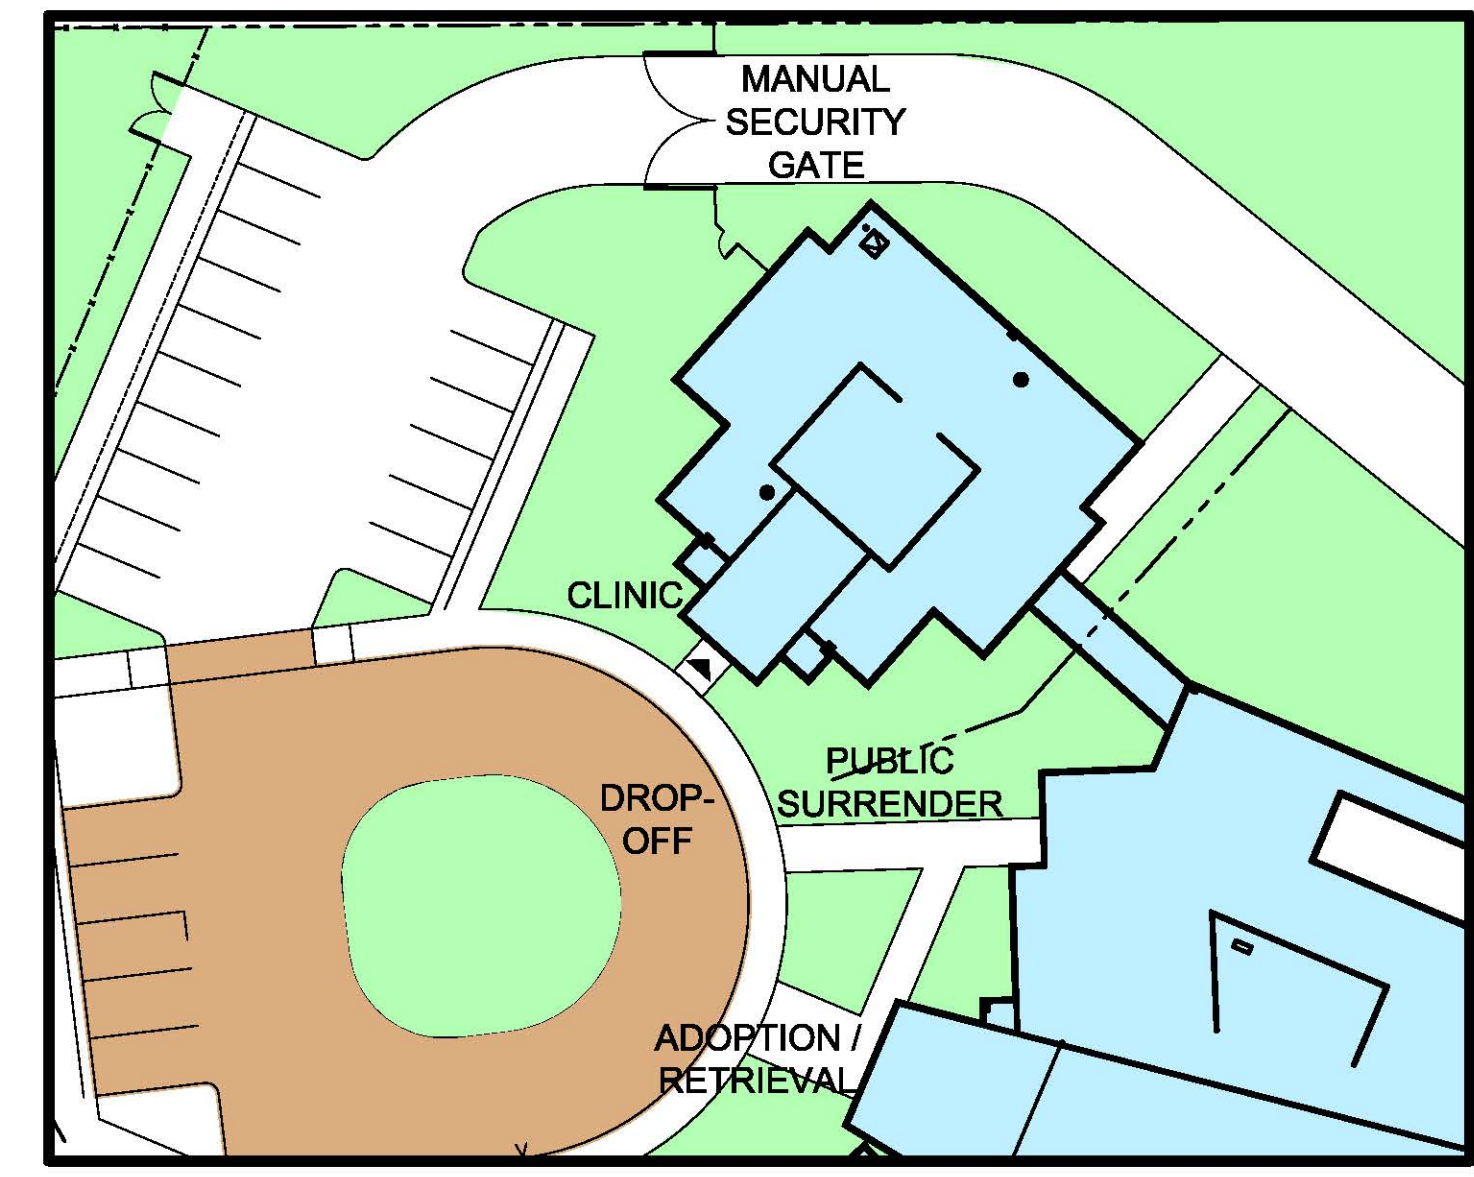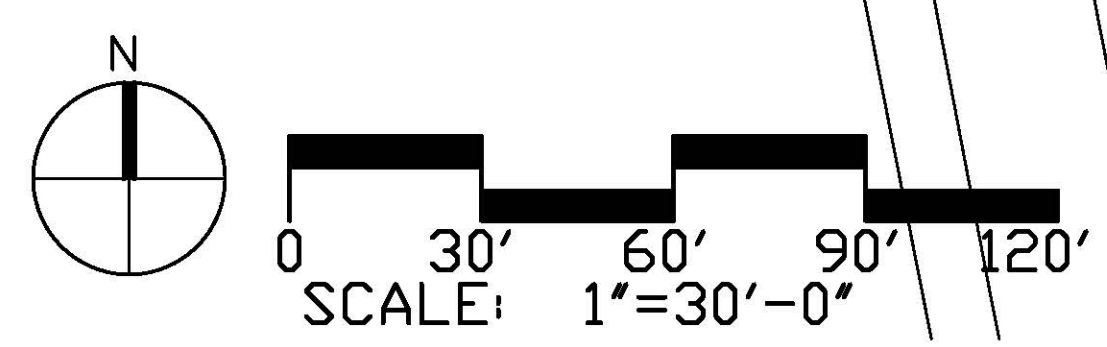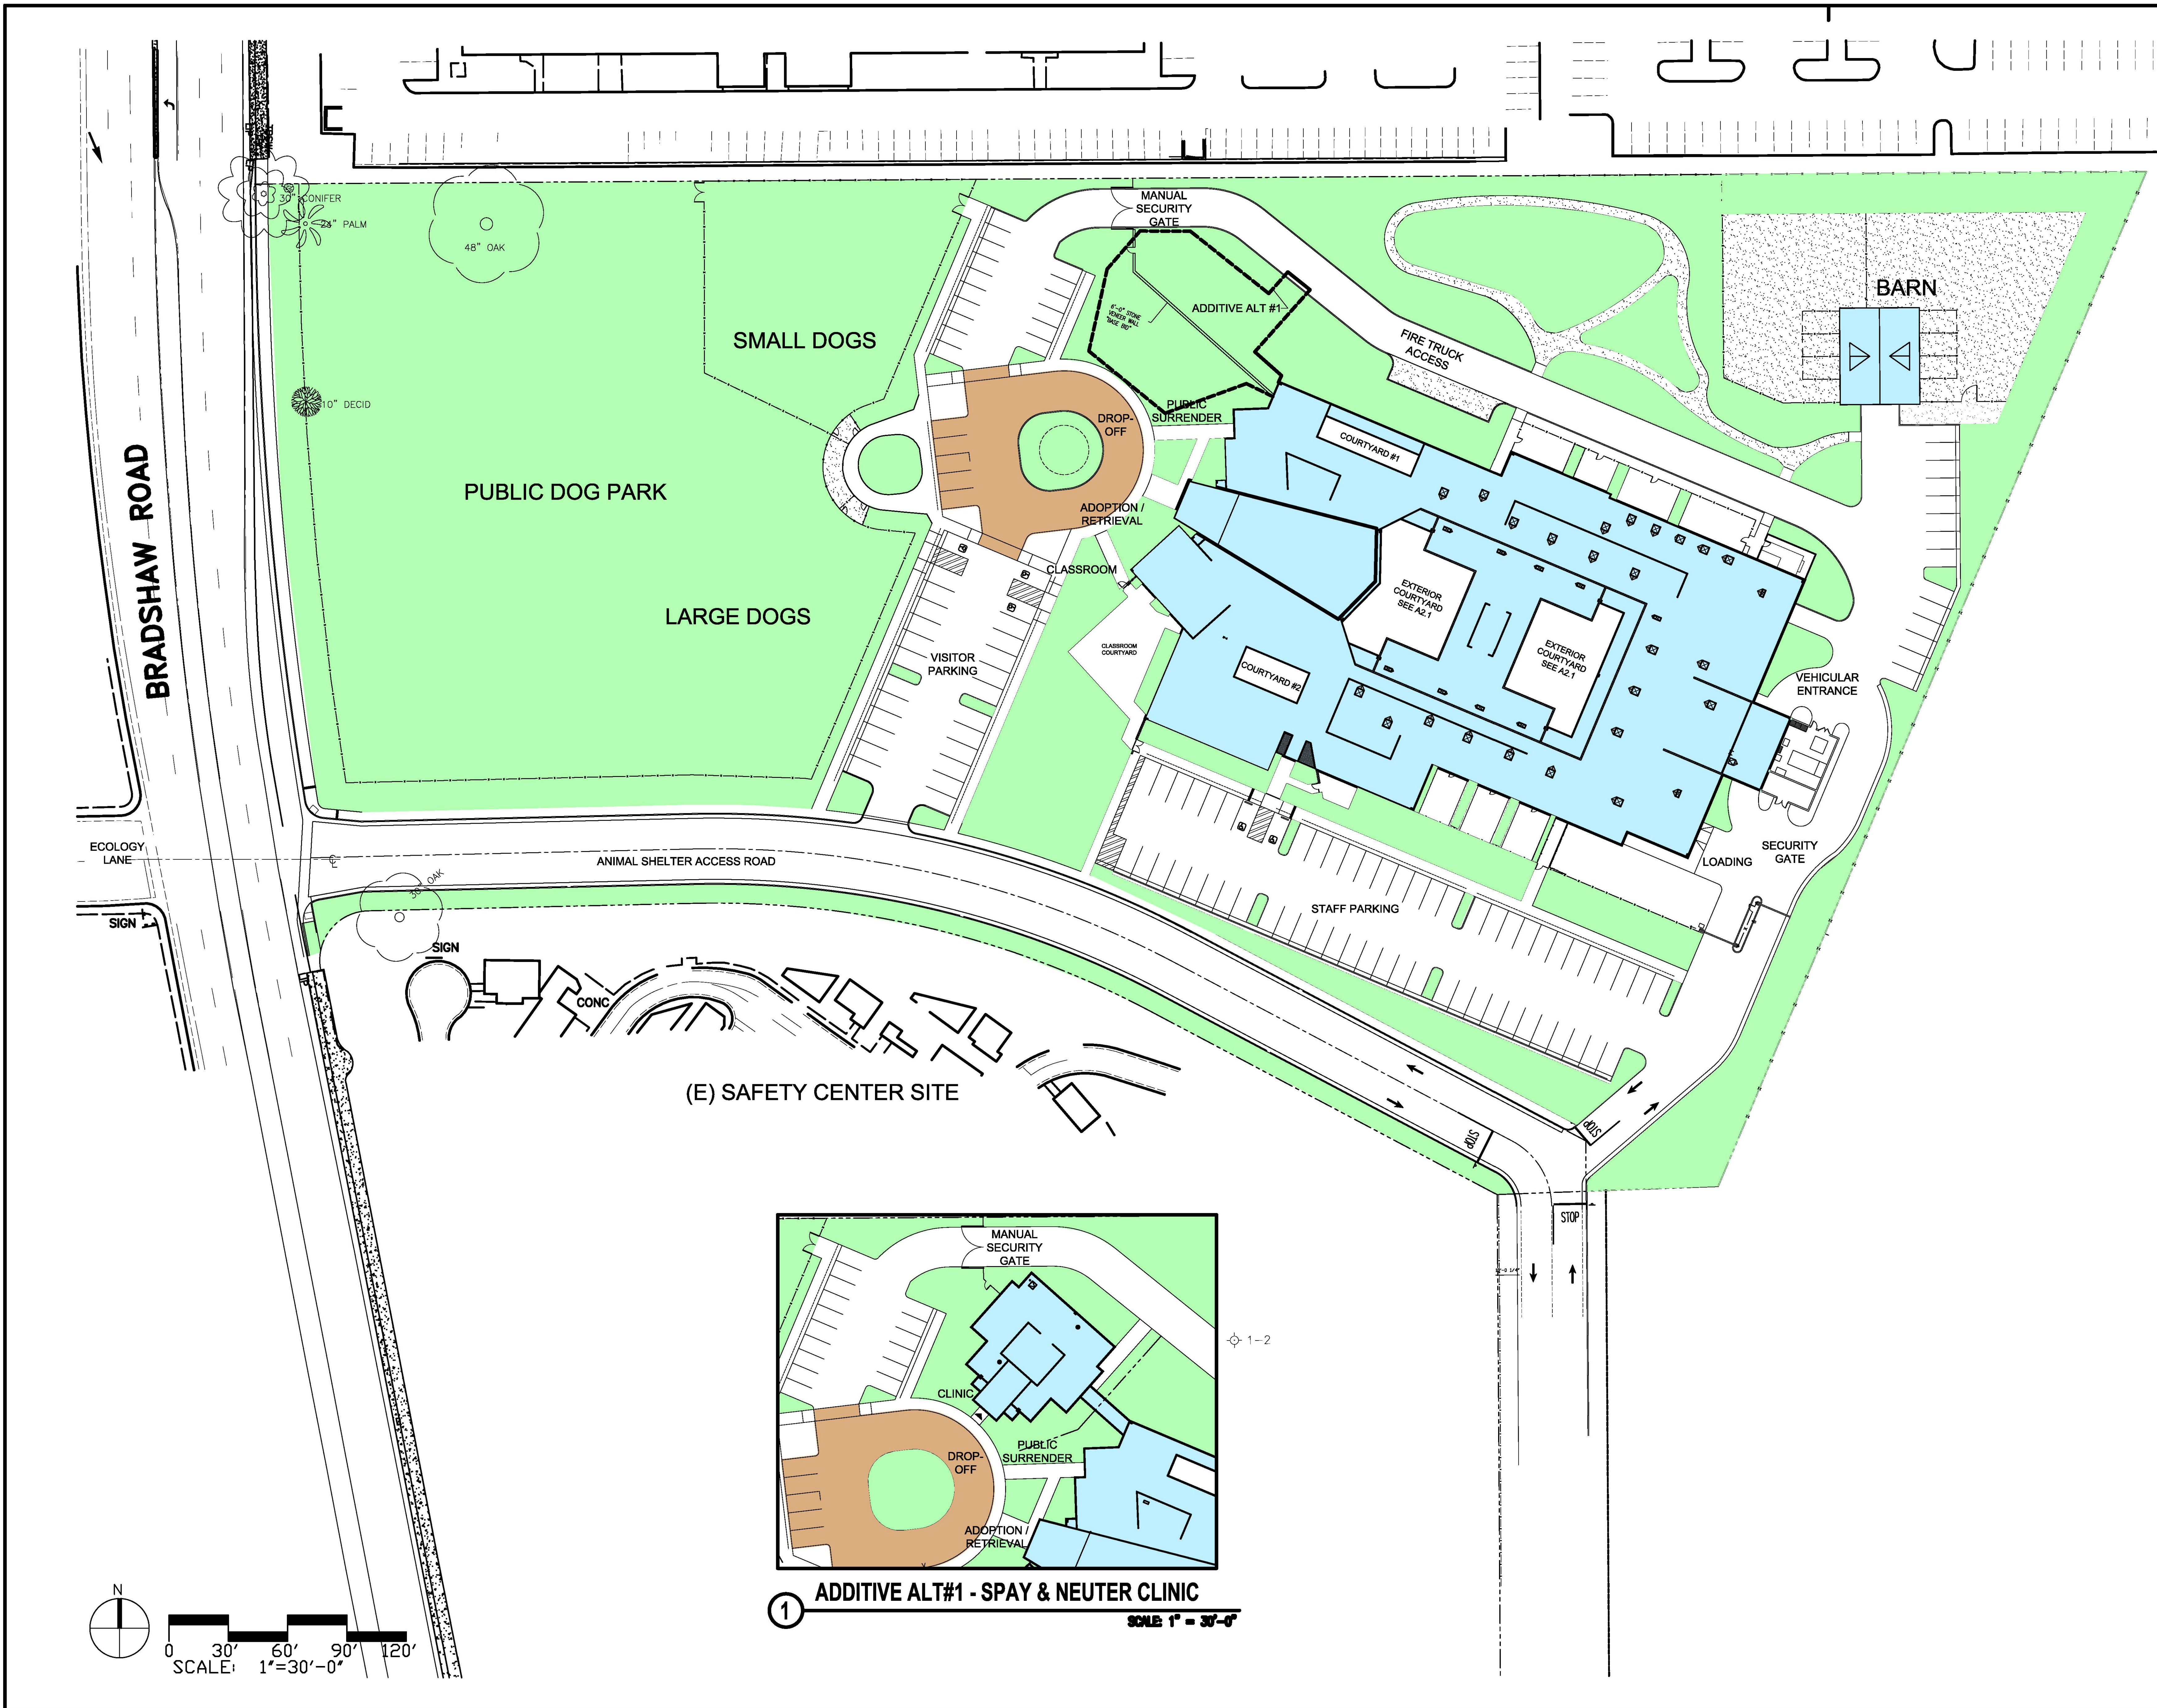

**1 ADDITIVE ALT#1 - SPAY & NEUTER CLINIC**  
SCALE 1" = 30'-0"